


LOCATE ELECTRICAL POWER POLE OR UNDER GROUND
 LOCATE ELECT. METER ON BUILDING
 ANY GAS LINES !!
 I STILL WANT TO BE MORE ACCURATE WITH LOCATION AND SIZE OF:
 - SEPTIC FIELD
 - SEPTIC TANK
 - WATER WELL.
 PROPOSED SITE PLAN
 SCALE: 1" = 10'



The survey map & report or the copies thereof are not valid without the digital signature and seal of a Florida licensed surveyor and mapper
 Date of Field Work : 04-24-2023
 Drawn By: Oleg
 Order #: 212123
 Last Revision Date: None
 Boundary Survey prepared by: LB8111
 NexGen Surveying, LLC
 561-508-6272
 1547 Prosperity Farms Rd
 West Palm Beach, FL 33403

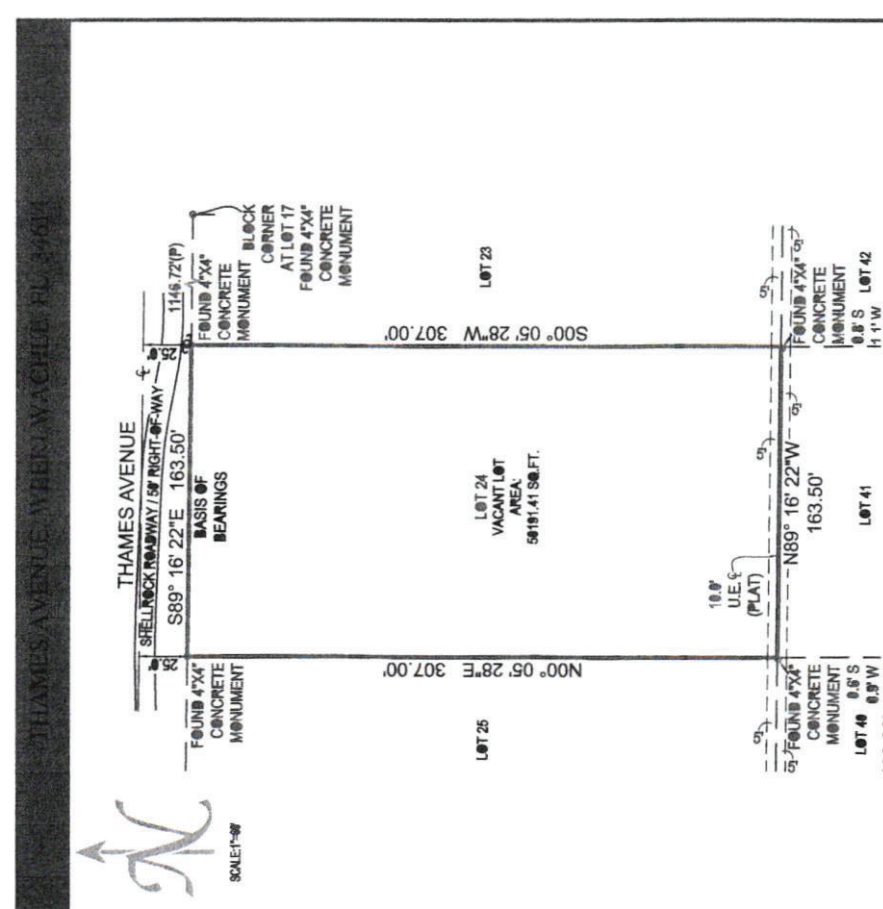

EXISTING SURVEY
 SCALE: 1" = 10'-0"